 


NOTES:

1. SEASONAL PLANTINGS SHALL CONSIST OF ANNUALS PLANTED IN THE SPRING AND FALL.
2. ALL PLANTING BEDS ALONG BROADWAY AND OSGOOD STREET WILL BE IRRIGATED.
3. A 6'-0" HIGH COMPOSITE FENCE SHALL BE INSTALLED ALONG THE SOUTH PROPERTY.
4. CONTRACTOR SHALL GUARANTEE PLANTINGS FOR ONE YEAR FROM INSTALLATION DATE.

Stamp:



L100

BROADWAY

OSGOOD STREET



UNIT MIX SUMMARY:

LEVEL 1
ENTRY LOBBY AND UTILITY SPACE
PARKING = 19 SPACES

UNIT TYPE	# OF UNITS
2 BED	5
1 BED	1
TOTAL UNITS	6

UNIT TYPE	# OF UNITS
2 BED	5
1 BED	1
TOTAL UNITS	6

UNIT TYPE	# OF UNITS
2 BED	5
1 BED	1
TOTAL UNITS	6

TOTAL UNITS = 18
AVERAGE 2 BED UNIT = 1,170 +/- NSF
AVERAGE 1 BED UNIT = 680 +/- NSF
AMENITIES:
PACKAGE ROOM, BIKE STORAGE

SQUARE FOOTAGE / FLOOR:

Ground Floor= 3,700 SF
2nd Floor= 8,425 SF
3rd Floor= 8,425 SF
4th Floor= 7,650 SF
Total GSF= 28,200 SF

LYFarchitects
LAGRASSE YANOWITZ & FEYL
Architecture • Land Planning • Construction Management
One Elm Square | Andover | MA | 01810
(978) 470.3675 | www.LYFarchitects.com

REGISTERED ARCHITECT
No. 20288
WAKEFIELD
MASS.
COMMONWEALTH OF MASSACHUSETTS

Stamp:

2 OSGOOD STREET

2 OSGOOD STREET, METHUEN MA


SITE AND GROUND LEVEL FLOOR PLAN

Prepared for: JOWANAR COMPANIES, LLC
Location: 300 BROADWAY, METHUEN, MA 01844

LYF 2021 ©
ALL PLANS, SPECIFICATIONS AND IDEAS ARE THE PROPERTY OF LYF. RIGHTS OF USE ARE CONDITIONAL AND ARE GRANTED UNDER FULL COMPENSATION AND LIMITED TO A ONE-TIME USE TO CONSTRUCT A SINGLE PROJECT ON THE SITE SO INDICATED. USE OF THE WORK AND ANY DERIVATIVE WORK COVERED UNDER THIS COPYRIGHT FOR OTHER PROJECTS IS PROHIBITED. THE USE OR REPRODUCTION OF THESE PLANS FOR ANY OTHER CONSTRUCTION OR PERMIT APPLICATION IS STRICTLY PROHIBITED WITHOUT PRIOR WRITTEN PERMISSION OF LYF

2	01.31.23	Comments
Mark	Date	
REVISIONS		
Date	12/06/2022	
Scale	As indicated	
Job No.	3077	
Sheet No.		


A100

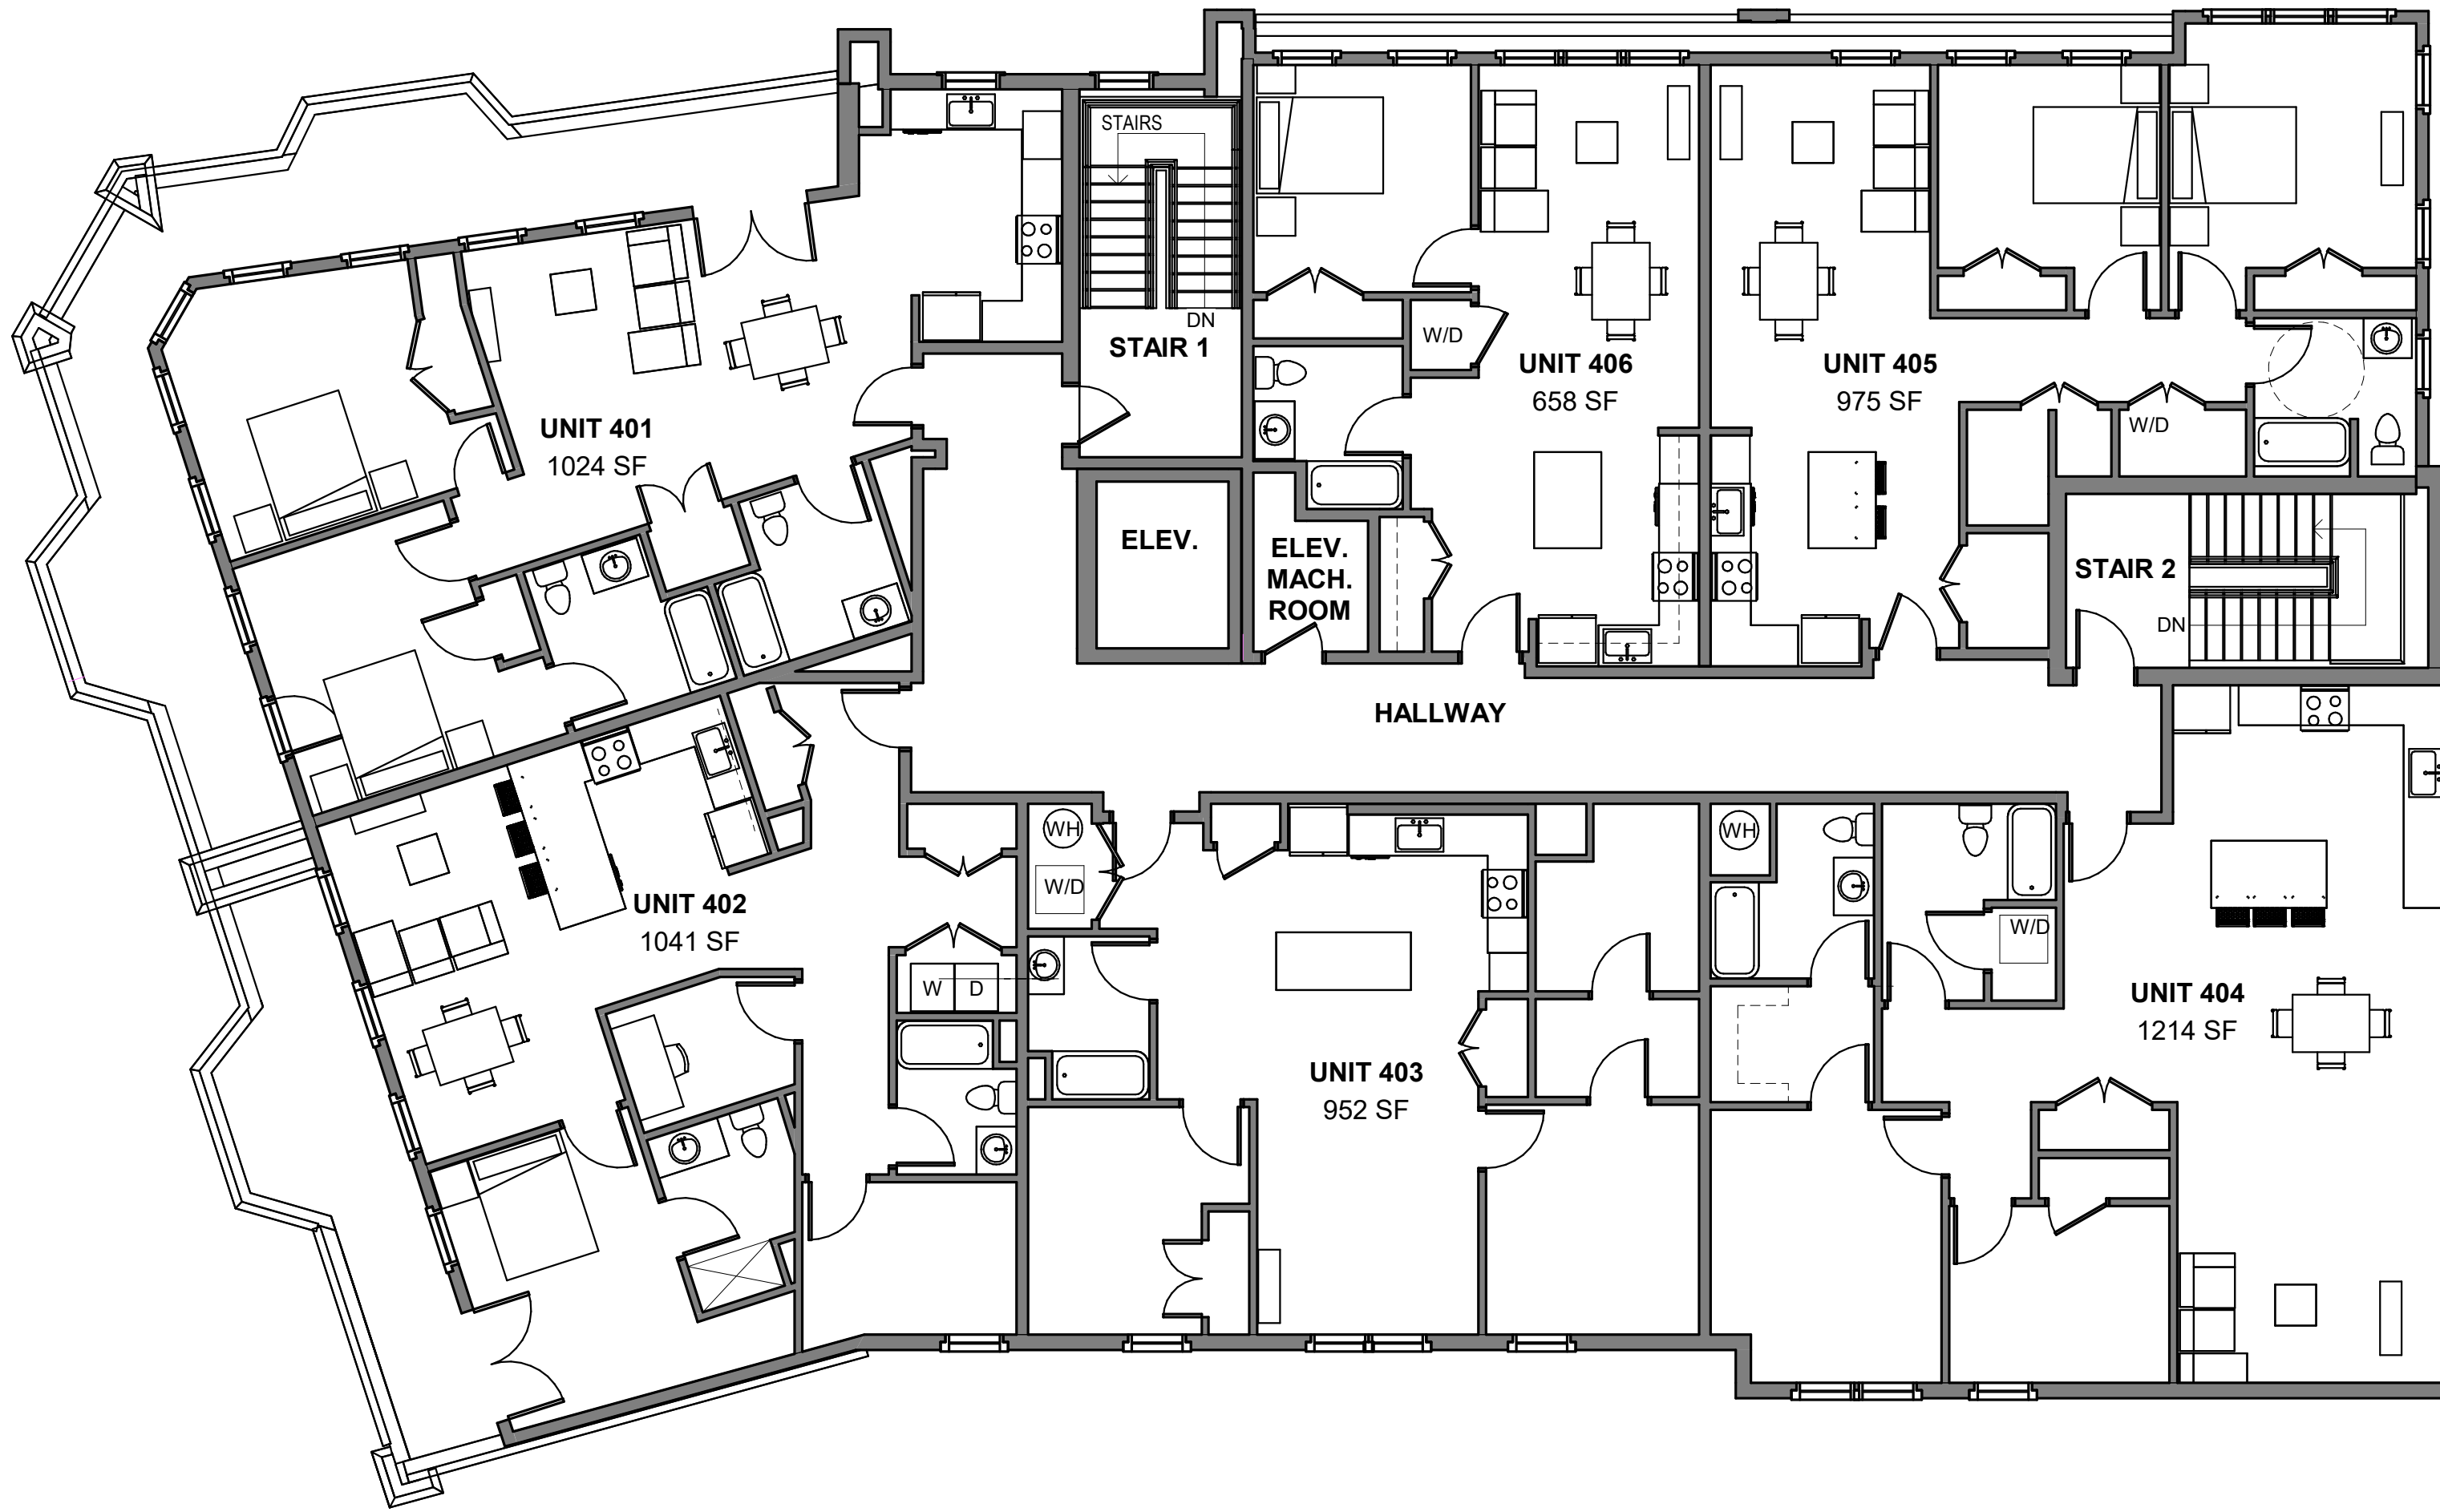


2 FOURTH FLOOR PLAN
1/8" = 1'-0"



1 THIRD FLOOR PLAN (TYPICAL AT
SECOND FLOOR)
1/8" = 1'-0"

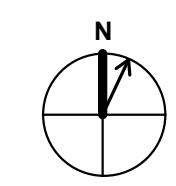

LYFarchitects
LAGRASSE YANOWITZ & FEYL
Architecture • Land Planning • Construction Management
One Elm Square | Andover | MA | 01810
(978) 470-3675 | www.LYFarchitects.com

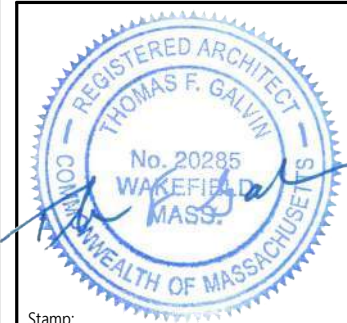

2 OSGOOD STREET
2 OSGOOD STREET, METHUEN MA

UPPER FLOOR PLANS

LYF 2021 ©
ALL PLANS, SPECIFICATIONS AND IDEAS ARE THE PROPERTY OF LYF. RIGHTS OF USE ARE CONDITIONAL AND ARE GRANTED UNDER FULL COMPENSATION AND LIMITED TO A ONE-TIME USE TO CONSTRUCT A SINGLE PROJECT ON THE SITE SO INDICATED. USE OF THE WORK AND ANY DERIVATIVE WORK COVERED UNDER THIS COPYRIGHT FOR OTHER PROJECTS IS PROHIBITED. THE USE OR REPRODUCTION OF THESE PLANS FOR ANY OTHER CONSTRUCTION OR PERMIT APPLICATION IS STRICTLY PROHIBITED WITHOUT PRIOR WRITTEN PERMISSION OF LYF.

2	01.31.23 Comments
1	11.29.22 Hist. Comm.
Mark	Date
REVISIONS	
Date	12/06/2022
Scale	As indicated
Job No.	3077
Sheet No.	

A101



4 East Elevation
1/8" = 1'-0"



3 South Elevation
1/8" = 1'-0"



2 North Elevation
1/8" = 1'-0"



1 West Elevation
1/8" = 1'-0"



Exterior Lighting Fixture Schedule				
Type Mark	Count	Manufacturer	Model	Image
A	6	Beacon Products	LAJ20-PT	
B	5	Architectural Area Lighting	UCS	
C	2	Lihonia Lighting	WDGE3	
D	9	Lihonia Lighting	CNY LED	
E	3	Beacon Products	LAJ20-PT	

LYFarchitects
LAGRASSE YANOWITZ & FEYL
Architecture • Land Planning • Construction Management
One Elm Square | Andover | MA | 01810
(978) 470.3675 | www.LYFarchitects.com

Stamp:

2 OSGOOD STREET

2 OSGOOD STREET, METHUEN MA

prepared for: JOWANAR COMPANIES, LLC
location: 300 BROADWAY, METHUEN, MA 01844

BUILDING ELEVATIONS

LYF 2021 ©
ALL PLANS, SPECIFICATIONS AND IDEAS ARE THE PROPERTY OF LYF. RIGHTS OF USE ARE CONDITIONAL AND ARE GRANTED UNDER FULL COMPENSATION AND LIMITED TO A ONE-TIME USE TO CONSTRUCT A SINGLE PROJECT ON THE SITE SO INDICATED. USE OF THE WORK AND ANY DERIVATIVE WORK COVERED UNDER THIS COPYRIGHT FOR OTHER PROJECTS IS PROHIBITED. THE USE OR REPRODUCTION OF THESE PLANS FOR ANY OTHER CONSTRUCTION OR PERMIT APPLICATION IS STRICTLY PROHIBITED WITHOUT PRIOR WRITTEN PERMISSION OF LYF

2	01.31.23 Comments
1	11.29.22 Hist. Comm.
Mark	Date
REVISIONS	
Date	12/06/2022
Scale	As indicated
Job No.	3077
Sheet No.	A200



3 OSGOOD STREET PERSPECTIVE



2 BROADWAY BUILDING PERSPECTIVE



1 OSGOOD - BROADWAY CORNER